


[illegible]

This drawing, as an instrument of service, is and shall remain the property of the Architect and shall not be reproduced, published or used in any way without the permission of the Architect.

PROJECT No.: 11115
DATE: 10-26-11
DRAWN BY: TMS
CHECKED BY: JBK

HEET


A-4

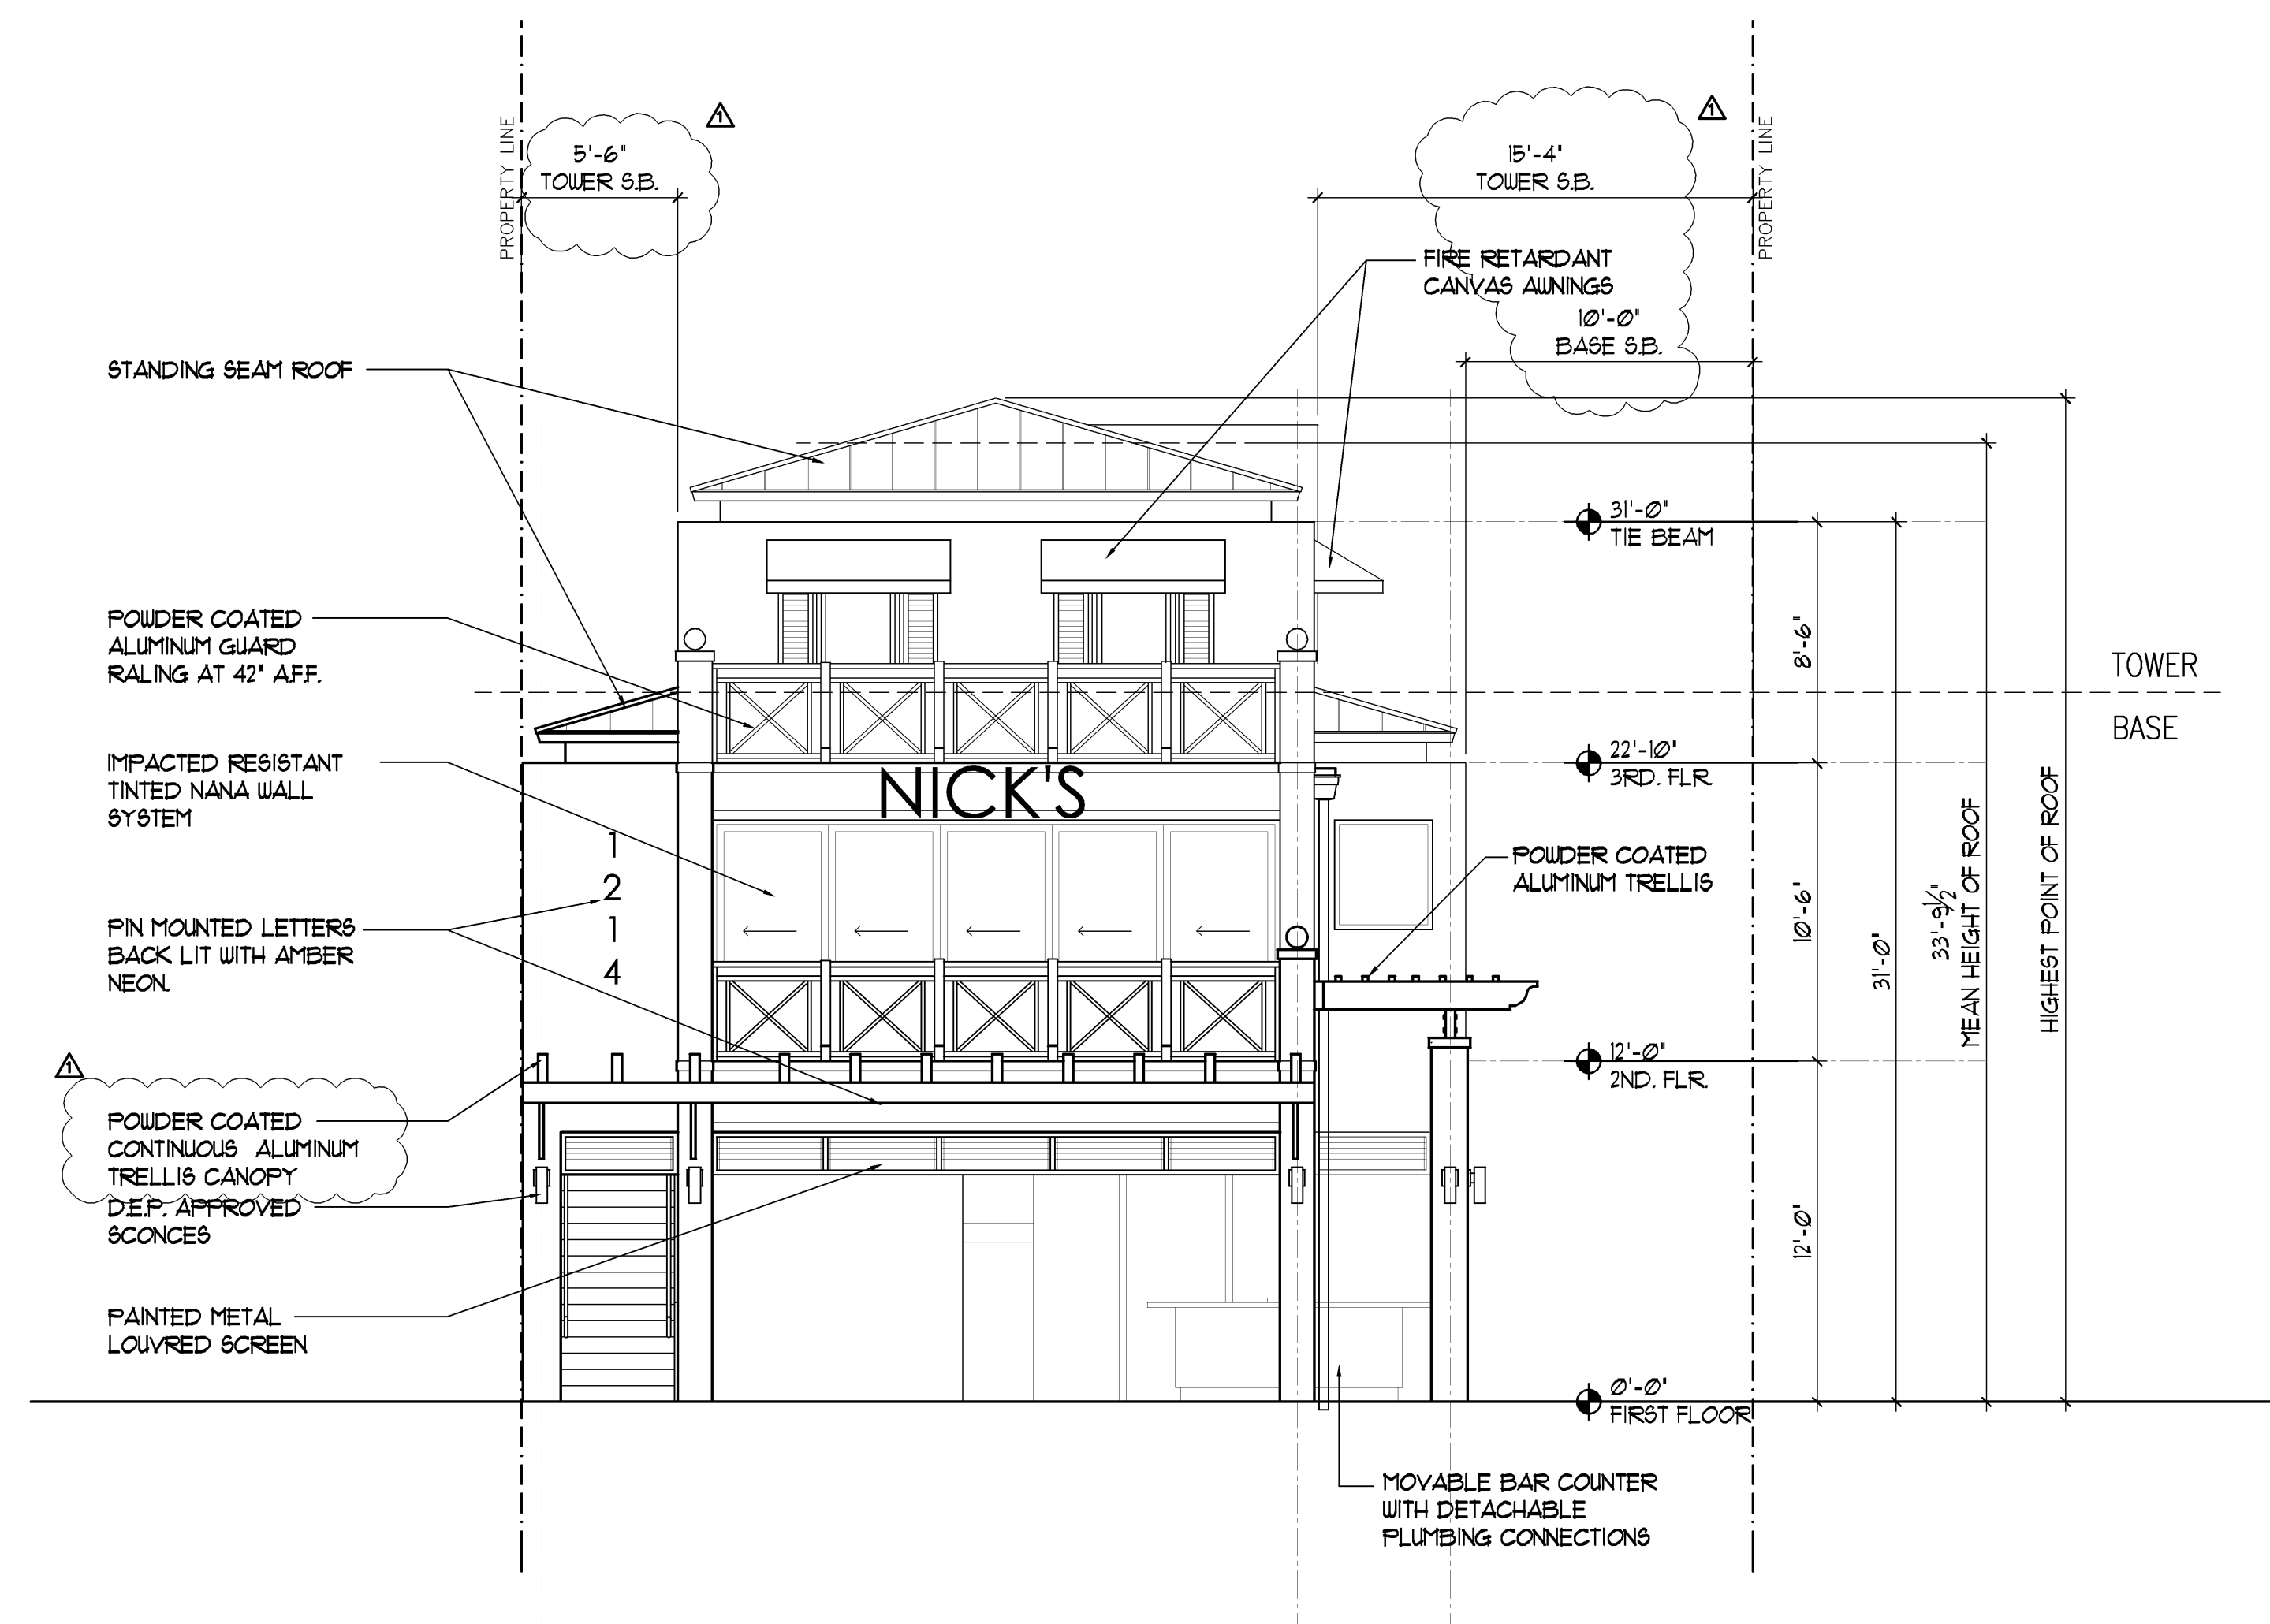

NOTE:
ALL EXTERIOR LIGHTING AS WELL AS LIGHTING ON
THE INTERIOR THAT CAN BE VIEWED FROM OUTSIDE
SHALL ADHERE TO THE FLORIDA FISH AND WILD
LIFE CONSERVATION COMMISSION REGARDING THE
PROTECTION OF MARINE TURTLES.
LIGHTING PLANS ARE TO BE SUBMITTED TO THE
"FWC" FOR REVIEW AND APPROVAL PRIOR TO
CONSTRUCTION.

1 | PROPOSED EAST ELEVATION

SCALE: 3/16" = 1'-0"

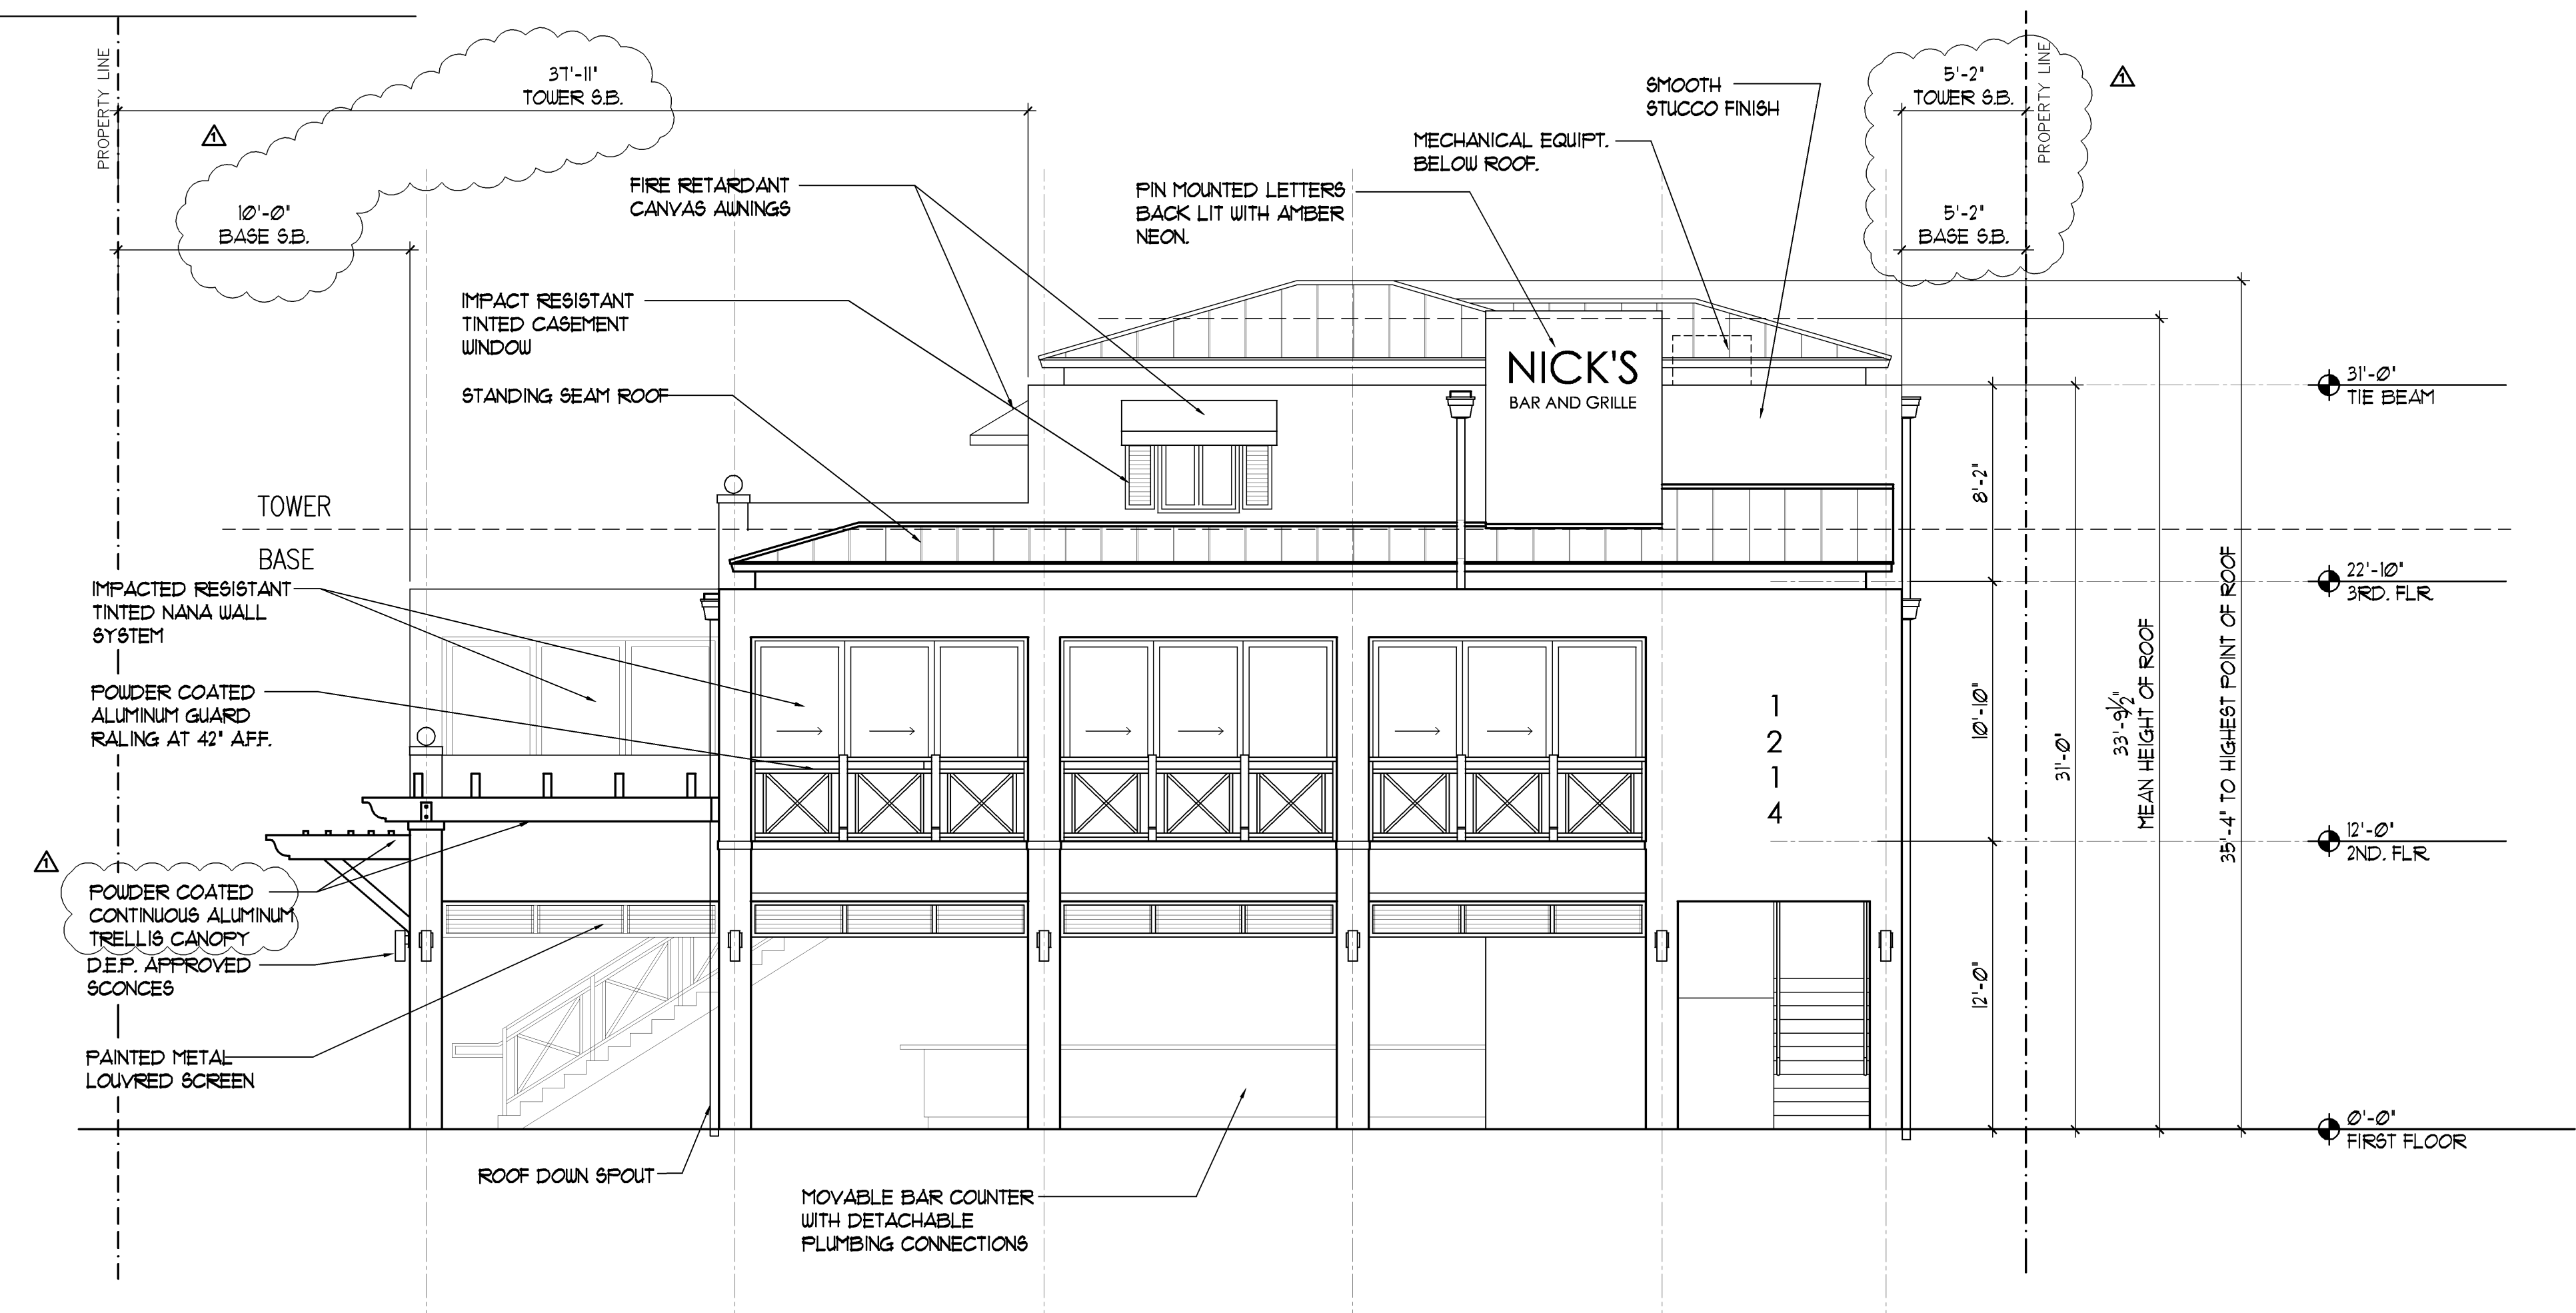

2 | PROPOSED NORTH ELEVATION

SCALE: 3/16" = 1'-0"