



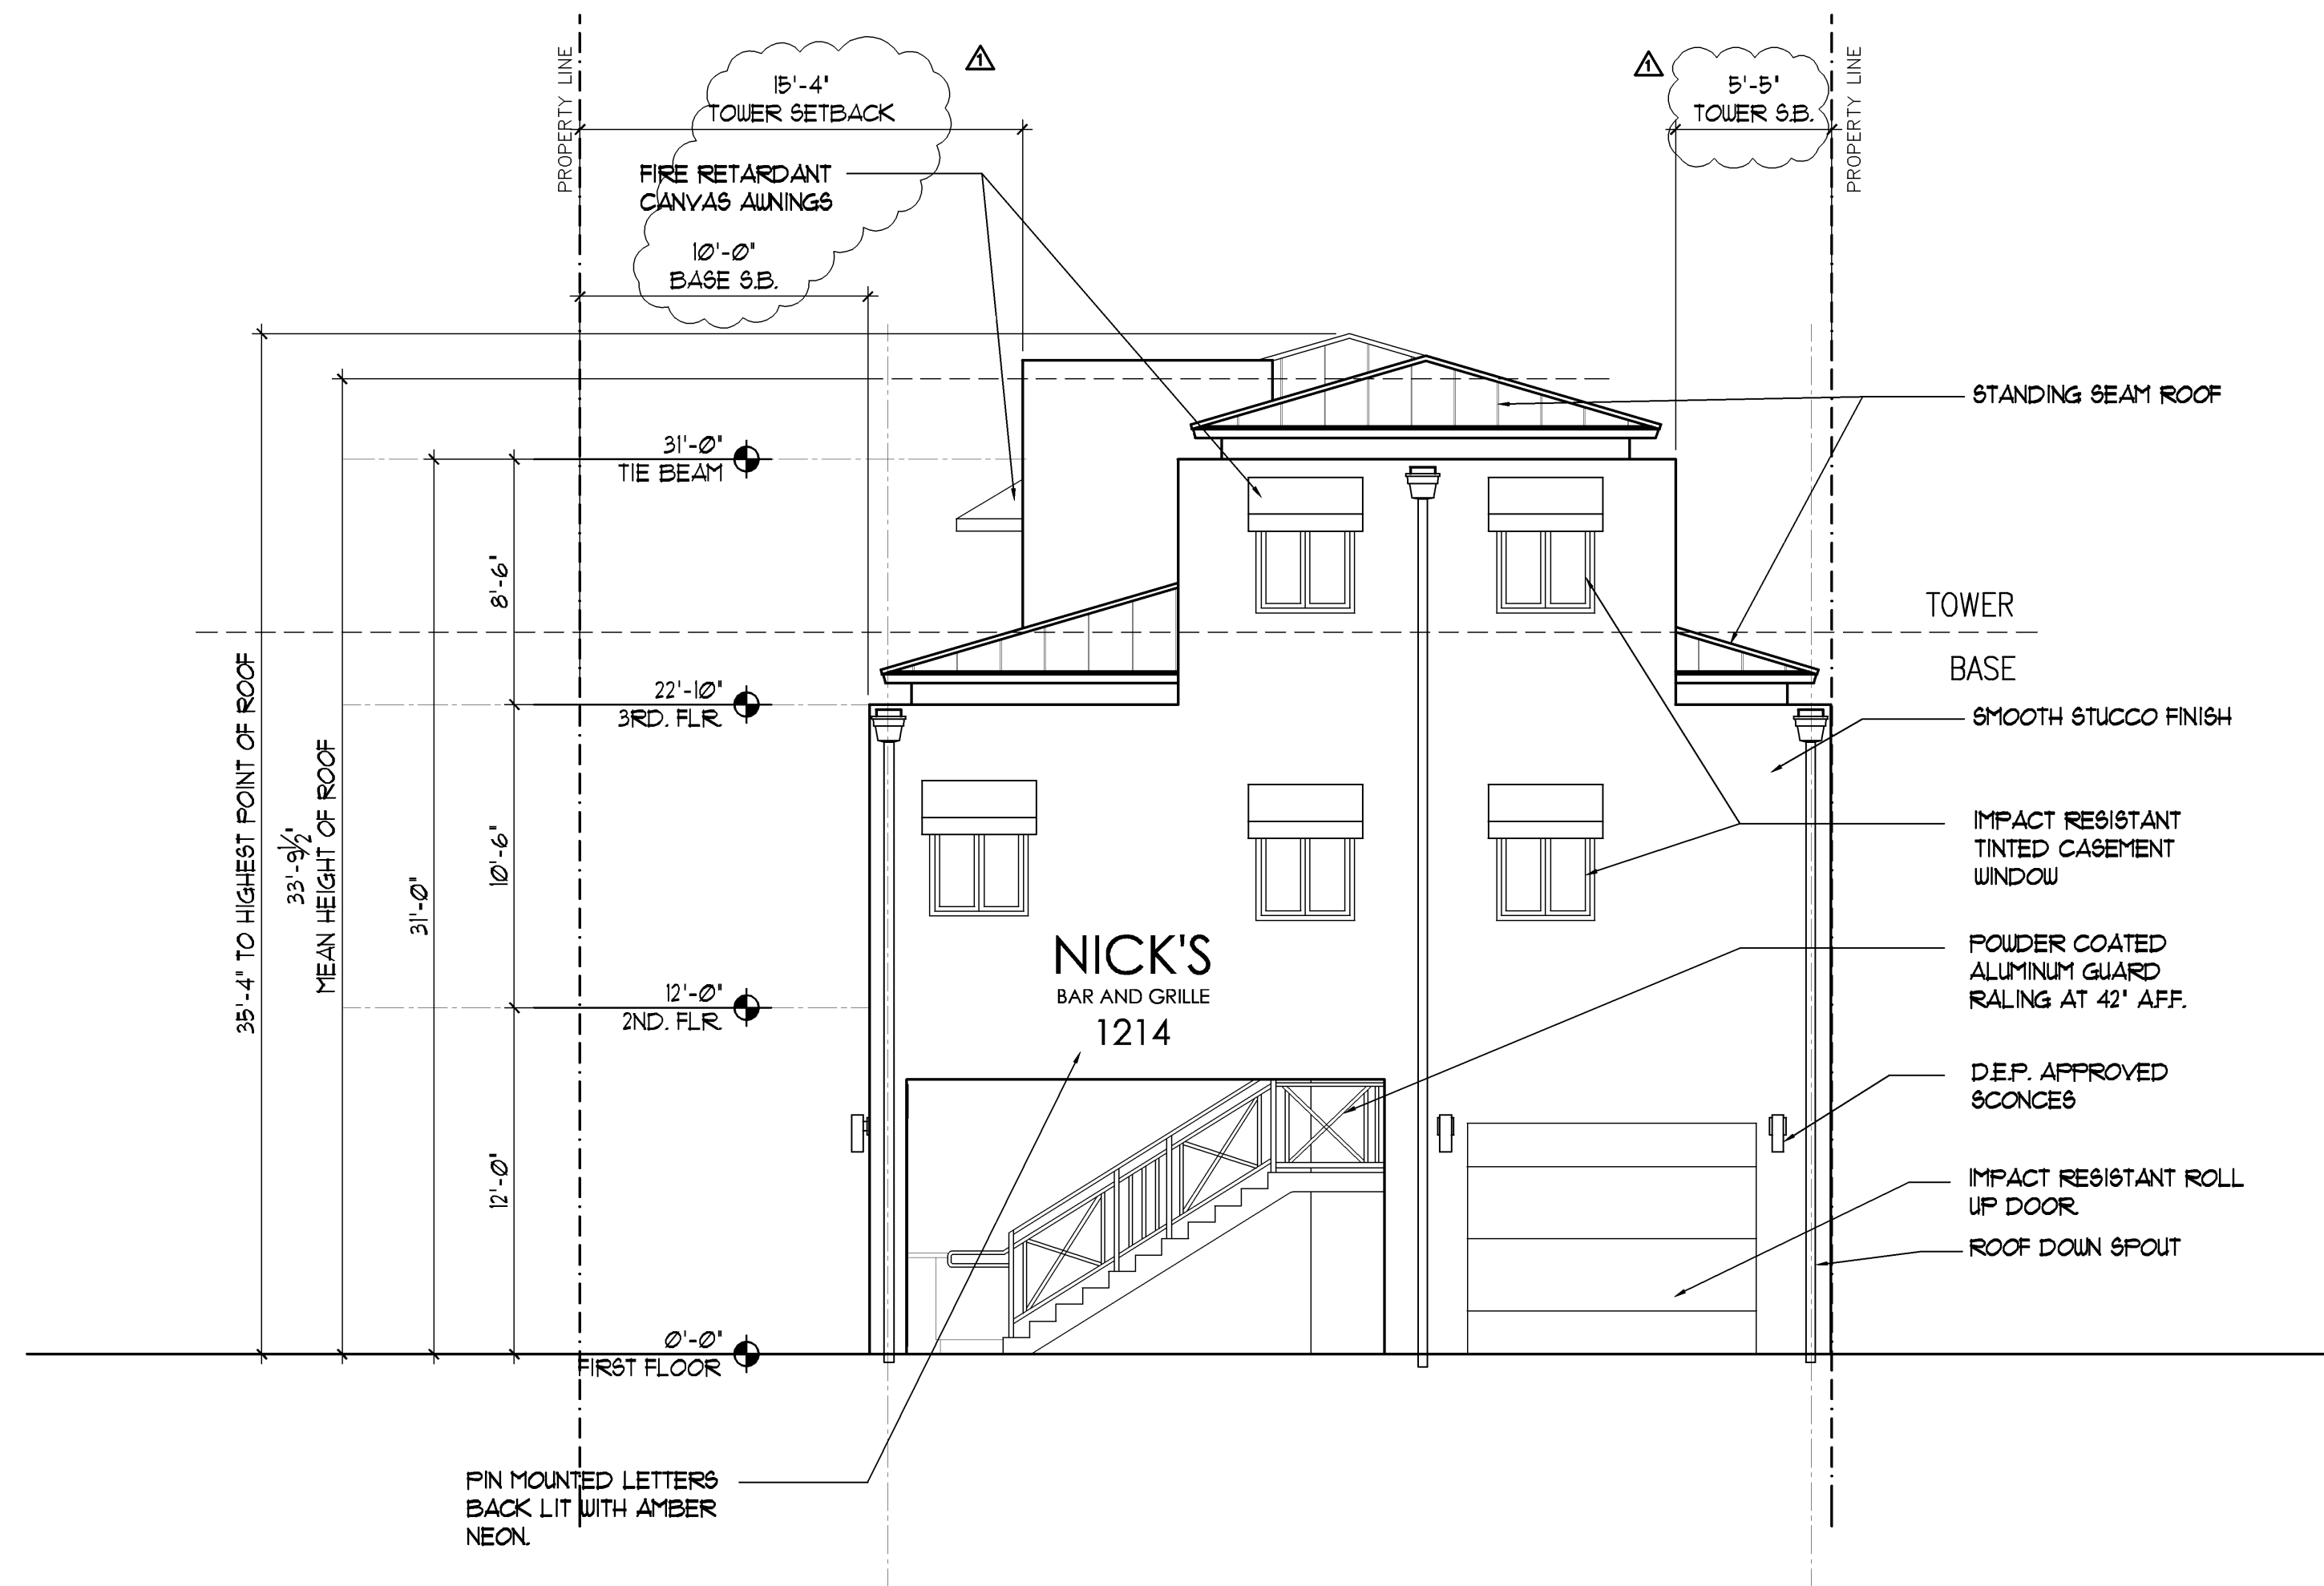

NOTE:
ALL EXTERIOR LIGHTING AS WELL AS LIGHTING ON
THE INTERIOR THAT CAN BE VIEWED FROM OUTSIDE
SHALL ADHERE TO THE FLORIDA FISH AND WILD
LIFE CONSERVATION COMMISSION REGARDING THE
PROTECTION OF MARINE TURTLES.
LIGHTING PLANS ARE TO BE SUBMITTED TO THE
'FWC' FOR REVIEW AND APPROVAL PRIOR TO
CONSTRUCTION.


1 | PROPOSED WEST ELEVATION

SCALE: 3/16" = 1'-0"

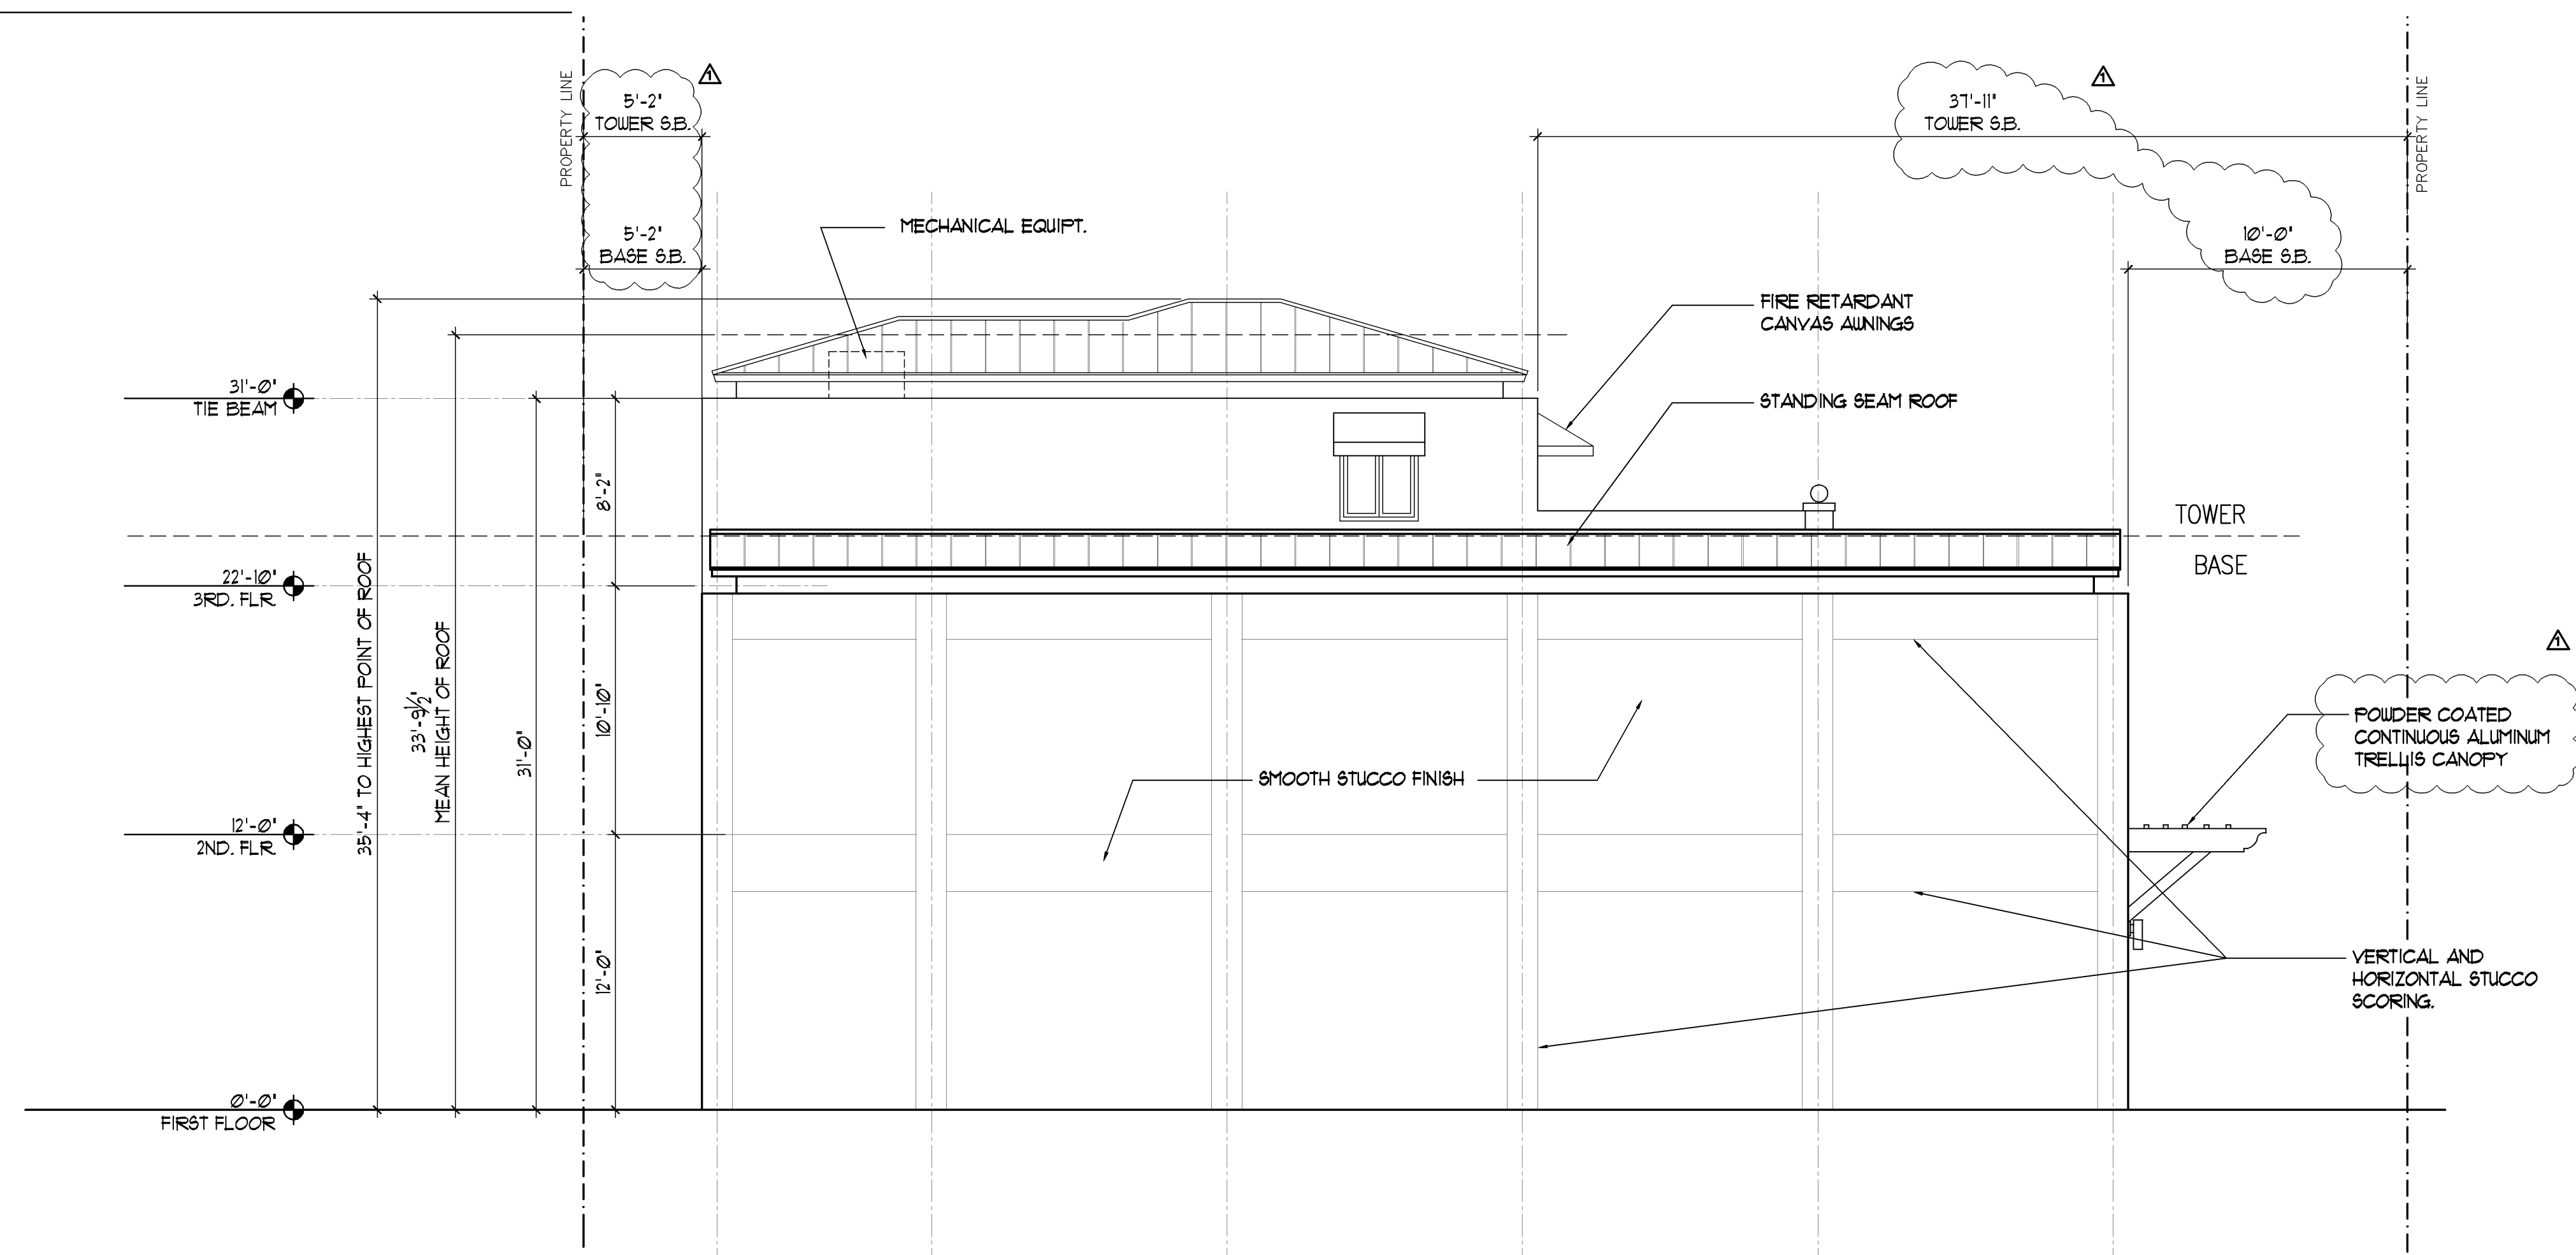

2 | PROPOSED SOUTH ELEVATION

SCALE: 3/16" = 1'-0"

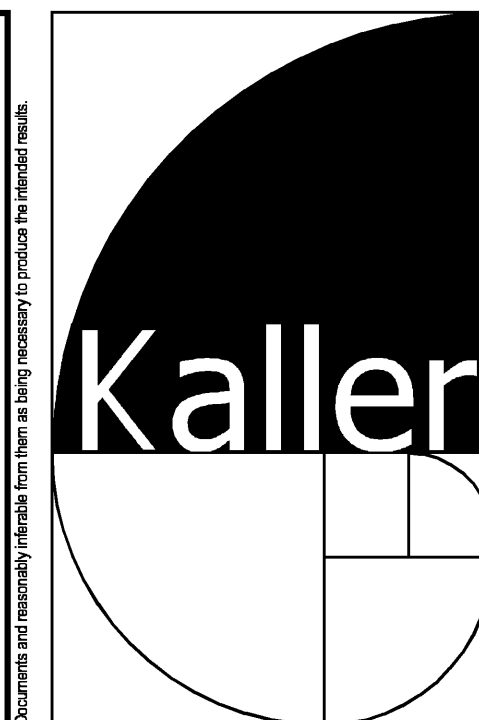

JOSEPH B. KALLER
&
ASSOCIATES, P.A.
AA# 26001212
2417 Hollywood Blvd., Hollywood, Florida 33020
P(954) 920 5746 phone - F(954) 926 2841
kaller@bellsouth.net

SEAL

JOSEPH B. KALLER
FLORIDA R.A. # 0009239

PROJECT TITLE
PROPOSED NEW CONSTRUCTION
NICK'S BAR & RESTAURANT
1214 N. BROADWALK
HOLLYWOOD BEACH, FLORIDA

SHEET TITLE
ELEVATIONS
FINAL TAC

REVISIONS		
No.	DATE	DESCRIPTION
1	1-2-12	PRELIM TAC

This drawing, as an instrument of service, is and shall remain the property of the Architect and shall not be reproduced, published or used in any way without the permission of the Architect.

PROJECT No.: 11115
DATE: 10-26-11
DRAWN BY: TMS
CHECKED BY: JBK

SHEET

A-5